

LAWRENCE GROUP

Austin Carolinas Denver New York St. Louis

CAMPANIA CAFE & MARKET

DAVIDSON, NC

PERMIT SET


OCTOBER 25, 2007

ARCHITECTURAL	
A001	APPENDIX B/U/L ASSEMBLY
A101	DEMOLITION & FLOOR PLAN
A111	ENLARGED PLAN & DETAILS
A201	INTERIOR ELEVATIONS
A301	FURNITURE & REFLECTED CEILING PLAN
PLUMBING	
P100	PLUMBING SPECS AND DETAILS
P200	PLUMBING FLOOR PLANS
FIRE PROTECTION	
FP100	FIRE PROTECTION SPECS, DETAILS AND FLOOR PLANS

MECHANICAL	
M100	MECHANICAL SPECS AND DETAILS
M200	MECHANICAL SCHEDULES, DEMO AND FLOOR PLANS
ELECTRICAL	
E100	ELECTRICAL SPECS AND DETAILS
E200	FLOOR PLAN LIGHTING
E300	FLOOR PLAN POWER
E400	SCHEDULES AND RISERS

SHEET INDEX

TYPICAL MOUNTING HEIGHTS
MOUNTING HEIGHTS ARE IN FEET AND INCHES ABOVE FINISHED FLOOR. TYPICAL MOUNTING HEIGHTS SHALL BE USED UNLESS NOTED OTHERWISE. NOTE NOT ALL ACCESSORIES MAY BE USED.

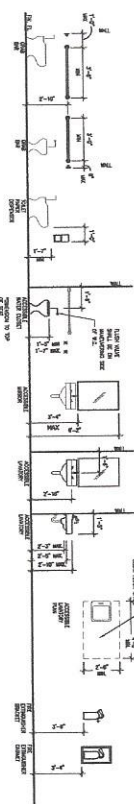

OCCUPANCY SUMMARY			
SPACE	SF / PERSON	OCCUPANCY	REQUIRED MIN PERSON
OFFICE & DINING	1.44	123	1
KITCHEN	9.68	200	5
TOTALS	2755	123	128

MINIMUM SUBMITTED PER SECTION 419.07

THE NC PLUMBING CODE

ADA FIXTURE REQUIREMENTS

CONCRETE	PLUMBING	MECHANICAL	ELECTRICAL
CONCRETE MASONRY UNITS	ACROUSTICAL TILE	WOOD FRAMING	WOOD FRAMING
BRICK	WOOD FRAMING	WOOD FRAMING	WOOD FRAMING
STONE	WOOD FRAMING	WOOD FRAMING	WOOD FRAMING
METALS	WOOD FRAMING	WOOD FRAMING	WOOD FRAMING
COMPACTED GRAVEL	WOOD FRAMING	WOOD FRAMING	WOOD FRAMING
CRUSHED STONE	WOOD FRAMING	WOOD FRAMING	WOOD FRAMING
UNDERSTAINED BDL	WOOD FRAMING	WOOD FRAMING	WOOD FRAMING
ROOM NUMBER	DOOR NUMBER	WALL TO BE REMOVED	WALL TO BE REMOVED
DOOR NUMBER	DOOR NUMBER	DOOR TO BE REMOVED	DOOR TO BE REMOVED
WALL SECTION NUMBER	WALL SECTION NUMBER	EXIST PARTITION TO REMAIN	EXIST PARTITION TO REMAIN
SHEET NUMBER	SHEET NUMBER	NEW PARTITION	NEW PARTITION
BUILDING SECTION NUMBER	BUILDING SECTION NUMBER	NEW DOOR	NEW DOOR
SHEET NUMBER	SHEET NUMBER	NEW FINISH GRADE	NEW FINISH GRADE
PLUMBING FIXTURE	PLUMBING FIXTURE	EXIST GRADE	EXIST GRADE
MECHANICAL SECTION NUMBER	MECHANICAL SECTION NUMBER	NEW OR FINISH	NEW OR FINISH
SHEET NUMBER	SHEET NUMBER	CONTIGUOUS	CONTIGUOUS
REFERENCE POINT	REFERENCE POINT	EXISTING CONTIGUOUS	EXISTING CONTIGUOUS
REVISION MARK	REVISION MARK	EXISTING CONTIGUOUS	EXISTING CONTIGUOUS

GRAPHIC LEGEND

SYMBOL LEGEND

CAMPANIA CAFE & MARKET

MAIN STREET

DAVIDSON, NC

LAWRENCE GROUP
Austin Carolina Denver New York St. Louis

DATE: 10/25/07

PROJECT: CAMPANIA CAFE & MARKET

LOCATION: 100 S. 10TH ST., DAVIDSON, NC 28038

OWNER: CAMPANIA CAFE & MARKET

DESIGNER: LAWRENCE GROUP

PROJECT NO: 07-001

DATE: 10/25/07

BY: [Signature]

FOR: [Signature]

PROJECT NO: 07-001

DATE: 10/25/07

BY: [Signature]

FOR: [Signature]

PROJECT NO: 07-001

DATE: 10/25/07

BY: [Signature]

Project Title:	Campania Cafe and Market
Client:	Davidson, NC
Architect:	Lawrence Group
Engineer:	Campania Cafe and Market
Interior Designer:	Campania Cafe and Market
Contractor:	Campania Cafe and Market
Project Manager:	Campania Cafe and Market
Design Team:	Campania Cafe and Market
Project Number:	Campania Cafe and Market
Project Date:	Campania Cafe and Market
Project Location:	Campania Cafe and Market
Project Status:	Campania Cafe and Market

The following information is provided for your information only. It is not intended to be a contract. The actual contract is the contract between the client and the architect. The architect is not responsible for the construction of the project. The architect is only responsible for the design of the project.

DAVIDSON, NC

CAMPANIA CAFE & MARKET


MAIN STREET

REFLECTED CEILING AND FURNITURE PLAN

Project Number: A301
Scale: 1/8"=1'-0"
October 15, 2001


1 REFLECTED CEILING PLAN


SCALE: 1/8"=1'-0"

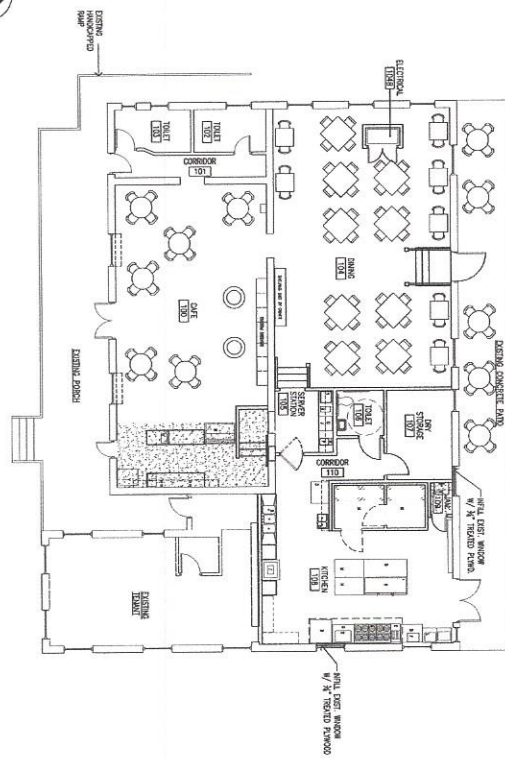


1 REFLECTED CEILING PLAN

SCALE: 1/8"=1'-0"

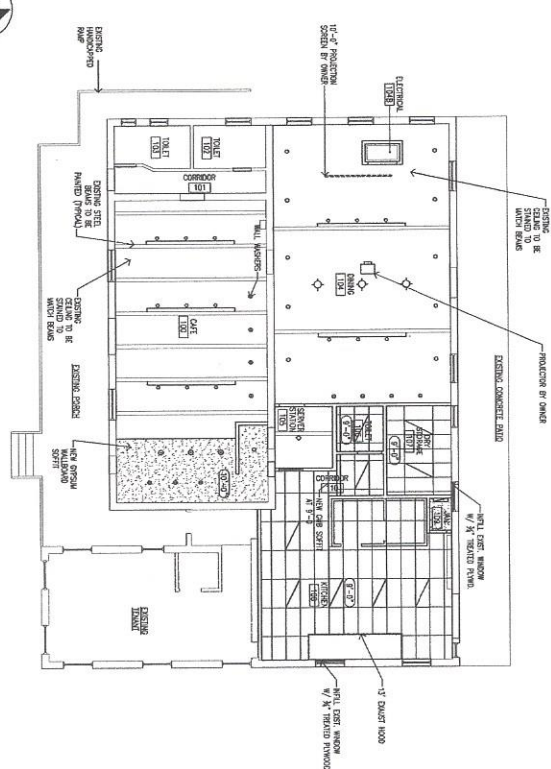

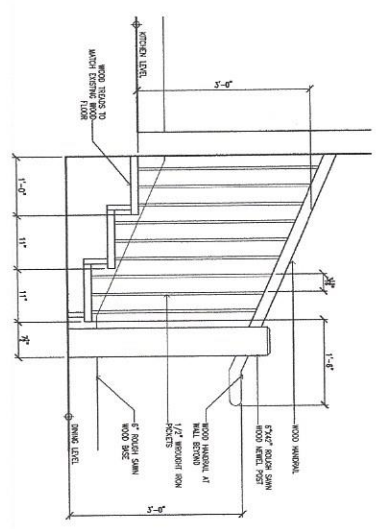

7 STAIR ELEVATION SCALE: 1"=1'-0"

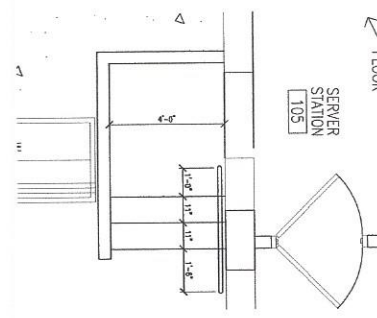


3 STAIR PLAN SCALE: 1/2"=1'-0"

KITCHEN EQUIPMENT LEGEND


A	CAS RESTAURANT RANGE	S	COMPARTMENT 120" WASHING SINK
B	CAS CONVECTION OVEN	T	COFFEE T
C	COFFEE/TEA CAS MOUNT CHAM. BLENDER	U	REFRIGERATOR
D	COFFEE/TEA CAS MOUNT CHAM. BLENDER	V	COFFEE MACHINE
E	COFFEE/TEA CAS MOUNT CHAM. BLENDER	W	ICE CUBE
F	COFFEE/TEA CAS MOUNT CHAM. BLENDER	X	EXPRESSO MACHINE
G	COFFEE/TEA CAS MOUNT CHAM. BLENDER	Y	REFRIGERATOR
H	COFFEE/TEA CAS MOUNT CHAM. BLENDER	Z	DISPOSAL
I	COFFEE/TEA CAS MOUNT CHAM. BLENDER	AA	WATER FILTERATION
J	COFFEE/TEA CAS MOUNT CHAM. BLENDER		
K	COFFEE/TEA CAS MOUNT CHAM. BLENDER		
L	COFFEE/TEA CAS MOUNT CHAM. BLENDER		
M	COFFEE/TEA CAS MOUNT CHAM. BLENDER		
N	COFFEE/TEA CAS MOUNT CHAM. BLENDER		
O	COFFEE/TEA CAS MOUNT CHAM. BLENDER		
P	COFFEE/TEA CAS MOUNT CHAM. BLENDER		
Q	COFFEE/TEA CAS MOUNT CHAM. BLENDER		
R	COFFEE/TEA CAS MOUNT CHAM. BLENDER		

GENERAL NOTE:
ALL KITCHEN EQUIPMENT TO BE PROVIDED BY THE OWNER AND INSTALLED BY THE CONTRACTOR.


2 KITCHEN EQUIPMENT LEGEND

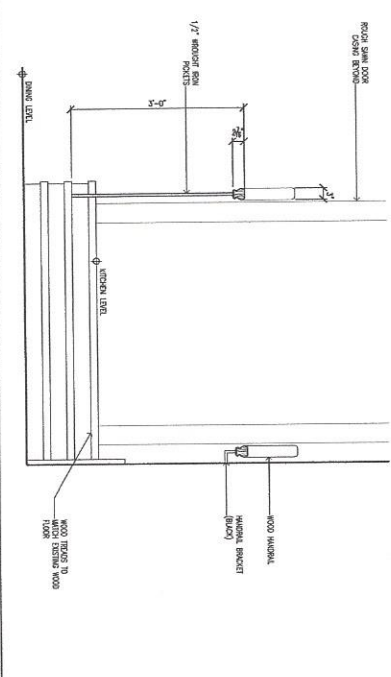

6 STAIR ELEVATION SCALE: 1"=1'-0"

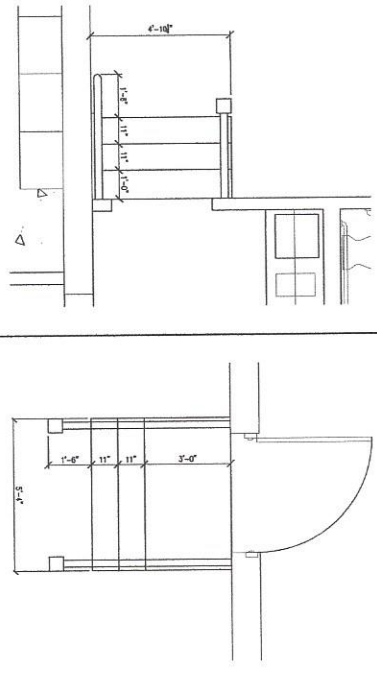

5 STAIR PLAN SCALE: 1/2"=1'-0"

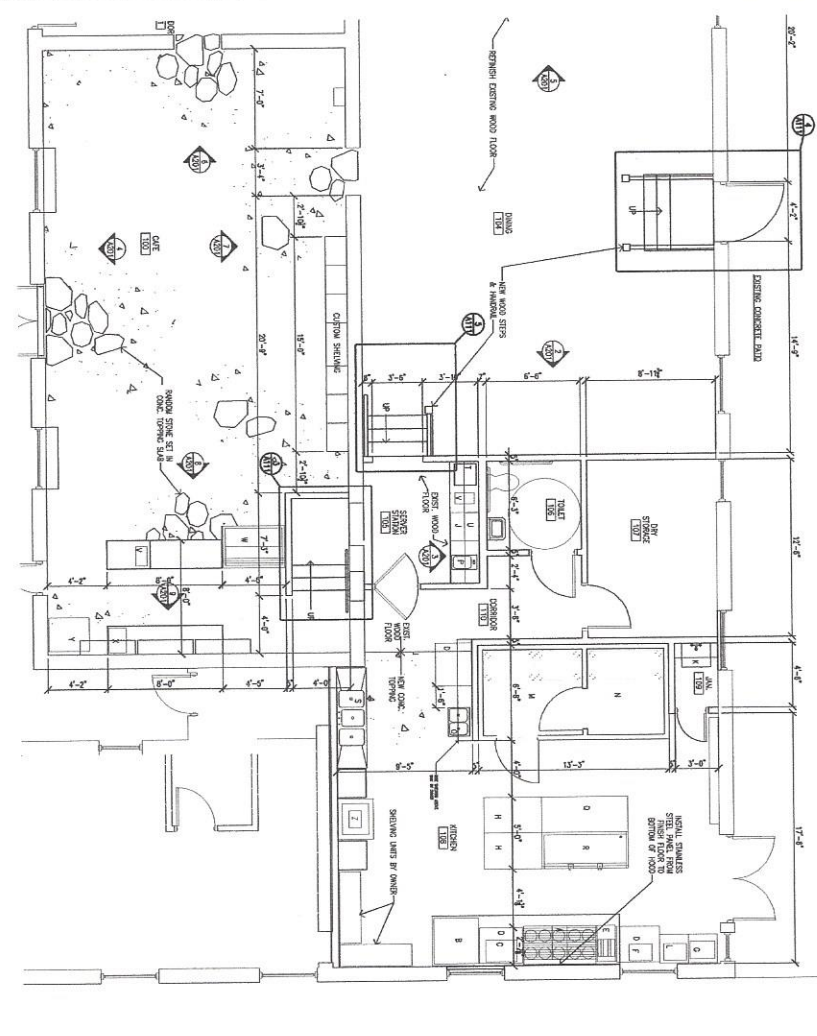

1 ENLARGED CAFE / KITCHEN PLAN SCALE: 1/4"=1'-0"

LAWRENCE GROUP
Architects
100 S. Main Street
Durham, NC 27601
Phone: 919.286.1234
Fax: 919.286.1235

Project Team:
Owner: Campania Cafe & Market
Architect: Lawrence Group
Engineer: [Blank]
Interior Designer: [Blank]
Landscape Architect: [Blank]
Civil Engineer: [Blank]
Mechanical Engineer: [Blank]
Electrical Engineer: [Blank]
Plumbing Engineer: [Blank]
HVAC Engineer: [Blank]
Fire Protection Engineer: [Blank]
Structural Engineer: [Blank]
Transportation Engineer: [Blank]
Traffic Engineer: [Blank]
Environmental Engineer: [Blank]
Historic Preservation: [Blank]
Archaeologist: [Blank]
Anthropologist: [Blank]
Botanist: [Blank]
Zoologist: [Blank]
Geologist: [Blank]
Hydrologist: [Blank]
Meteorologist: [Blank]
Oceanographer: [Blank]
Paleontologist: [Blank]
Physiologist: [Blank]
Psychologist: [Blank]
Sociologist: [Blank]
Virologist: [Blank]
Zoologist: [Blank]

CAMPANIA CAFE & MARKET
MAIN STREET
DAVIDSON, NC

ENLARGED PLANS AND DETAILS
Sheet No. A111
October 15, 2020